


UNSWITCHED HOT CONDUCTORS SHALL BE PROVIDED ON EACH CIRCUIT FOR ALL EMERGENCY EGRESS LIGHTING

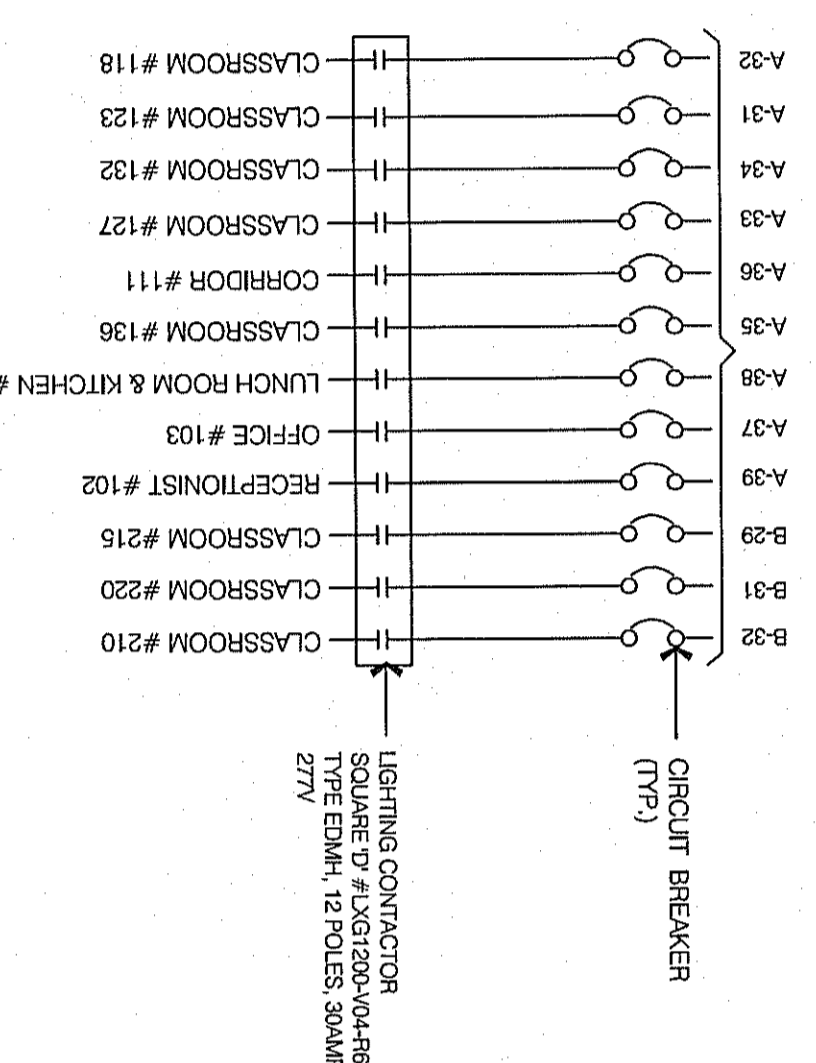

UNSWITCHED HOT CONDUCTORS SHALL BE PROVIDED ON EACH CIRCUIT FOR ALL EMERGENCY EGRESS LIGHTING

Note:
1. ELECTRICAL CONTRACTOR SHALL VERIFY ALL CONTACTOR FIELD WIRING REQUIREMENTS PRIOR TO BID.


CONTACTOR 'B' WIRING DIAGRAM N.T.S. **8**

Note:
1. ELECTRICAL CONTRACTOR SHALL VERIFY ALL CONTACTOR FIELD WIRING REQUIREMENTS PRIOR TO BID.


CONTACTOR 'A' WIRING DIAGRAM N.T.S. **7**

NO.	QUANTITY	LOCATION	MANUFACTURER / CATALOG NUMBER	DESCRIPTION	#	LAMP	TYPE	HOURLY	VOLTS	WATT	REMARKS
A	SEE PLAN	GENERAL	ULTRONIA 281R-281S-120-GE992-PLM83P	2x4 FLOURESCENT	2	28 TR	RECESSED	SEE PLAN	120	96	
B	SEE PLAN	GENERAL	ULTRONIA 182-283B-15-FL28S	RECESSED DOWNLIGHT	2	14 TR	RECESSED	SEE PLAN	120	28	
C	SEE PLAN	GENERAL	ULTRONIA 219D1T 120	FLUOR	1	REFLECTOR	SEE PLAN	120	23		
D	SEE PLAN	GENERAL	ULTRONIA 140 ES	2x4 FLOURESCENT	2	18	SURFACE	SEE PLAN	120	32	
E	SEE PLAN	GENERAL	ULTRONIA 219S 120 G.R	RECESSED DOWNLIGHT	2	INCANDE	RECESSED	SEE PLAN	120	75	
F	SEE PLAN	GENERAL	219S 171R 120 G.R	INCANDE	2	REFLECTOR	SEE PLAN	120	17		
G	SEE PLAN	EXTENSION	ULTRONIA 140 FT W/ 310P	INCANDE	1	REFLECTOR	SEE PLAN	120	13		
H	SEE PLAN	EXTENSION	ULTRONIA 140 FT W/ 310P	INCANDE	2	REFLECTOR	SEE PLAN	120	13		
I	SEE PLAN	EXTENSION	ULTRONIA 140 FT W/ 310P	INCANDE	2	REFLECTOR	SEE PLAN	120	13		
J	SEE PLAN	EXTENSION	ULTRONIA 140 FT W/ 310P	INCANDE	2	REFLECTOR	SEE PLAN	120	13		
K	SEE PLAN	EXTENSION	ULTRONIA 140 FT W/ 310P	INCANDE	2	REFLECTOR	SEE PLAN	120	13		
L	SEE PLAN	EXTENSION	ULTRONIA 140 FT W/ 310P	INCANDE	2	REFLECTOR	SEE PLAN	120	13		
M	SEE PLAN	EXTENSION	ULTRONIA 140 FT W/ 310P	INCANDE	2	REFLECTOR	SEE PLAN	120	13		
N	SEE PLAN	EXTENSION	ULTRONIA 140 FT W/ 310P	INCANDE	2	REFLECTOR	SEE PLAN	120	13		
O	SEE PLAN	EXTENSION	ULTRONIA 140 FT W/ 310P	INCANDE	2	REFLECTOR	SEE PLAN	120	13		
P	SEE PLAN	EXTENSION	ULTRONIA 140 FT W/ 310P	INCANDE	2	REFLECTOR	SEE PLAN	120	13		
Q	SEE PLAN	EXTENSION	ULTRONIA 140 FT W/ 310P	INCANDE	2	REFLECTOR	SEE PLAN	120	13		
R	SEE PLAN	EXTENSION	ULTRONIA 140 FT W/ 310P	INCANDE	2	REFLECTOR	SEE PLAN	120	13		
S	SEE PLAN	EXTENSION	ULTRONIA 140 FT W/ 310P	INCANDE	2	REFLECTOR	SEE PLAN	120	13		
T	SEE PLAN	EXTENSION	ULTRONIA 140 FT W/ 310P	INCANDE	2	REFLECTOR	SEE PLAN	120	13		
U	SEE PLAN	EXTENSION	ULTRONIA 140 FT W/ 310P	INCANDE	2	REFLECTOR	SEE PLAN	120	13		
V	SEE PLAN	EXTENSION	ULTRONIA 140 FT W/ 310P	INCANDE	2	REFLECTOR	SEE PLAN	120	13		
W	SEE PLAN	EXTENSION	ULTRONIA 140 FT W/ 310P	INCANDE	2	REFLECTOR	SEE PLAN	120	13		
X	SEE PLAN	EXTENSION	ULTRONIA 140 FT W/ 310P	INCANDE	2	REFLECTOR	SEE PLAN	120	13		
Y	SEE PLAN	EXTENSION	ULTRONIA 140 FT W/ 310P	INCANDE	2	REFLECTOR	SEE PLAN	120	13		
Z	SEE PLAN	EXTENSION	ULTRONIA 140 FT W/ 310P	INCANDE	2	REFLECTOR	SEE PLAN	120	13		

LIGHT FIXTURE SCHEDULE N.T.S. **6**

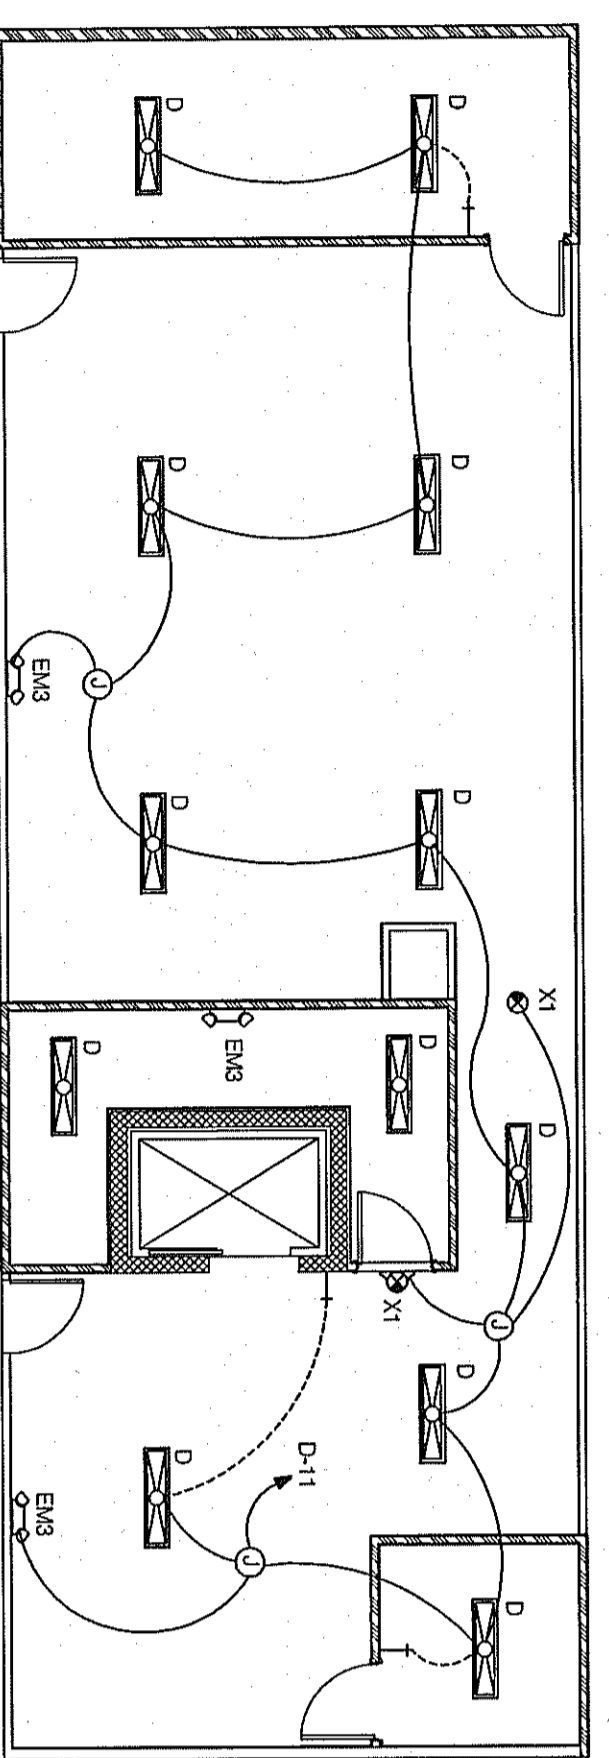


ATTIC LIGHTING PLAN SCALE: 1/8" = 1'-0"

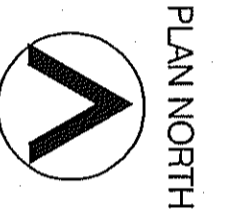

- ELECTRICAL CONTRACTOR SHALL CONSIDER LIGHTING FIXTURE QUANTITIES WITH SUPPLIER.
- EMERGENCY AND NORMAL LIGHTING MARKED WITH "NLS" SUBSCRIPT SHALL OPERATE CONTINUOUSLY. PROVIDE UNSWITCHED HOT TO NORMAL AND EMERGENCY BALLAST.
- EMERGENCY LIGHTING NOT MARKED WITH "NLS" SUBSCRIPT SHALL OPERATE UNDER CONTROL OF LIGHTING SWITCH AS INDICATED. PROVIDE UNSWITCHED CONDUIT NOT TO EXCEED 12 INCHES AND MARKED "NLS" TO NORMAL BALLAST.
- EMERGENCY LIGHTING SHALL BE PROVIDED IN ALL AREAS.
- ELECTRICAL CONTRACTOR TO FIELD VERIFY CEILING TYPE AND PROVIDE PROPER MOUNTING HARDWARE.
- THE DIRECTIVE, IF ANY, OF THE BUILDING OFFICIAL SHALL TAKE PRECEDENCE OVER THE PLANS REGARDING LOCATION AND NUMBER OF EXIST AND EMERGENCY LIGHT FIXTURES.
- REFER TO REFLECTED CEILING PLAN FOR LIGHT FIXTURE DIMENSIONED LOCATIONS.



NOT USED N.T.S. **4**

GENERAL NOTES N.T.S. **3**

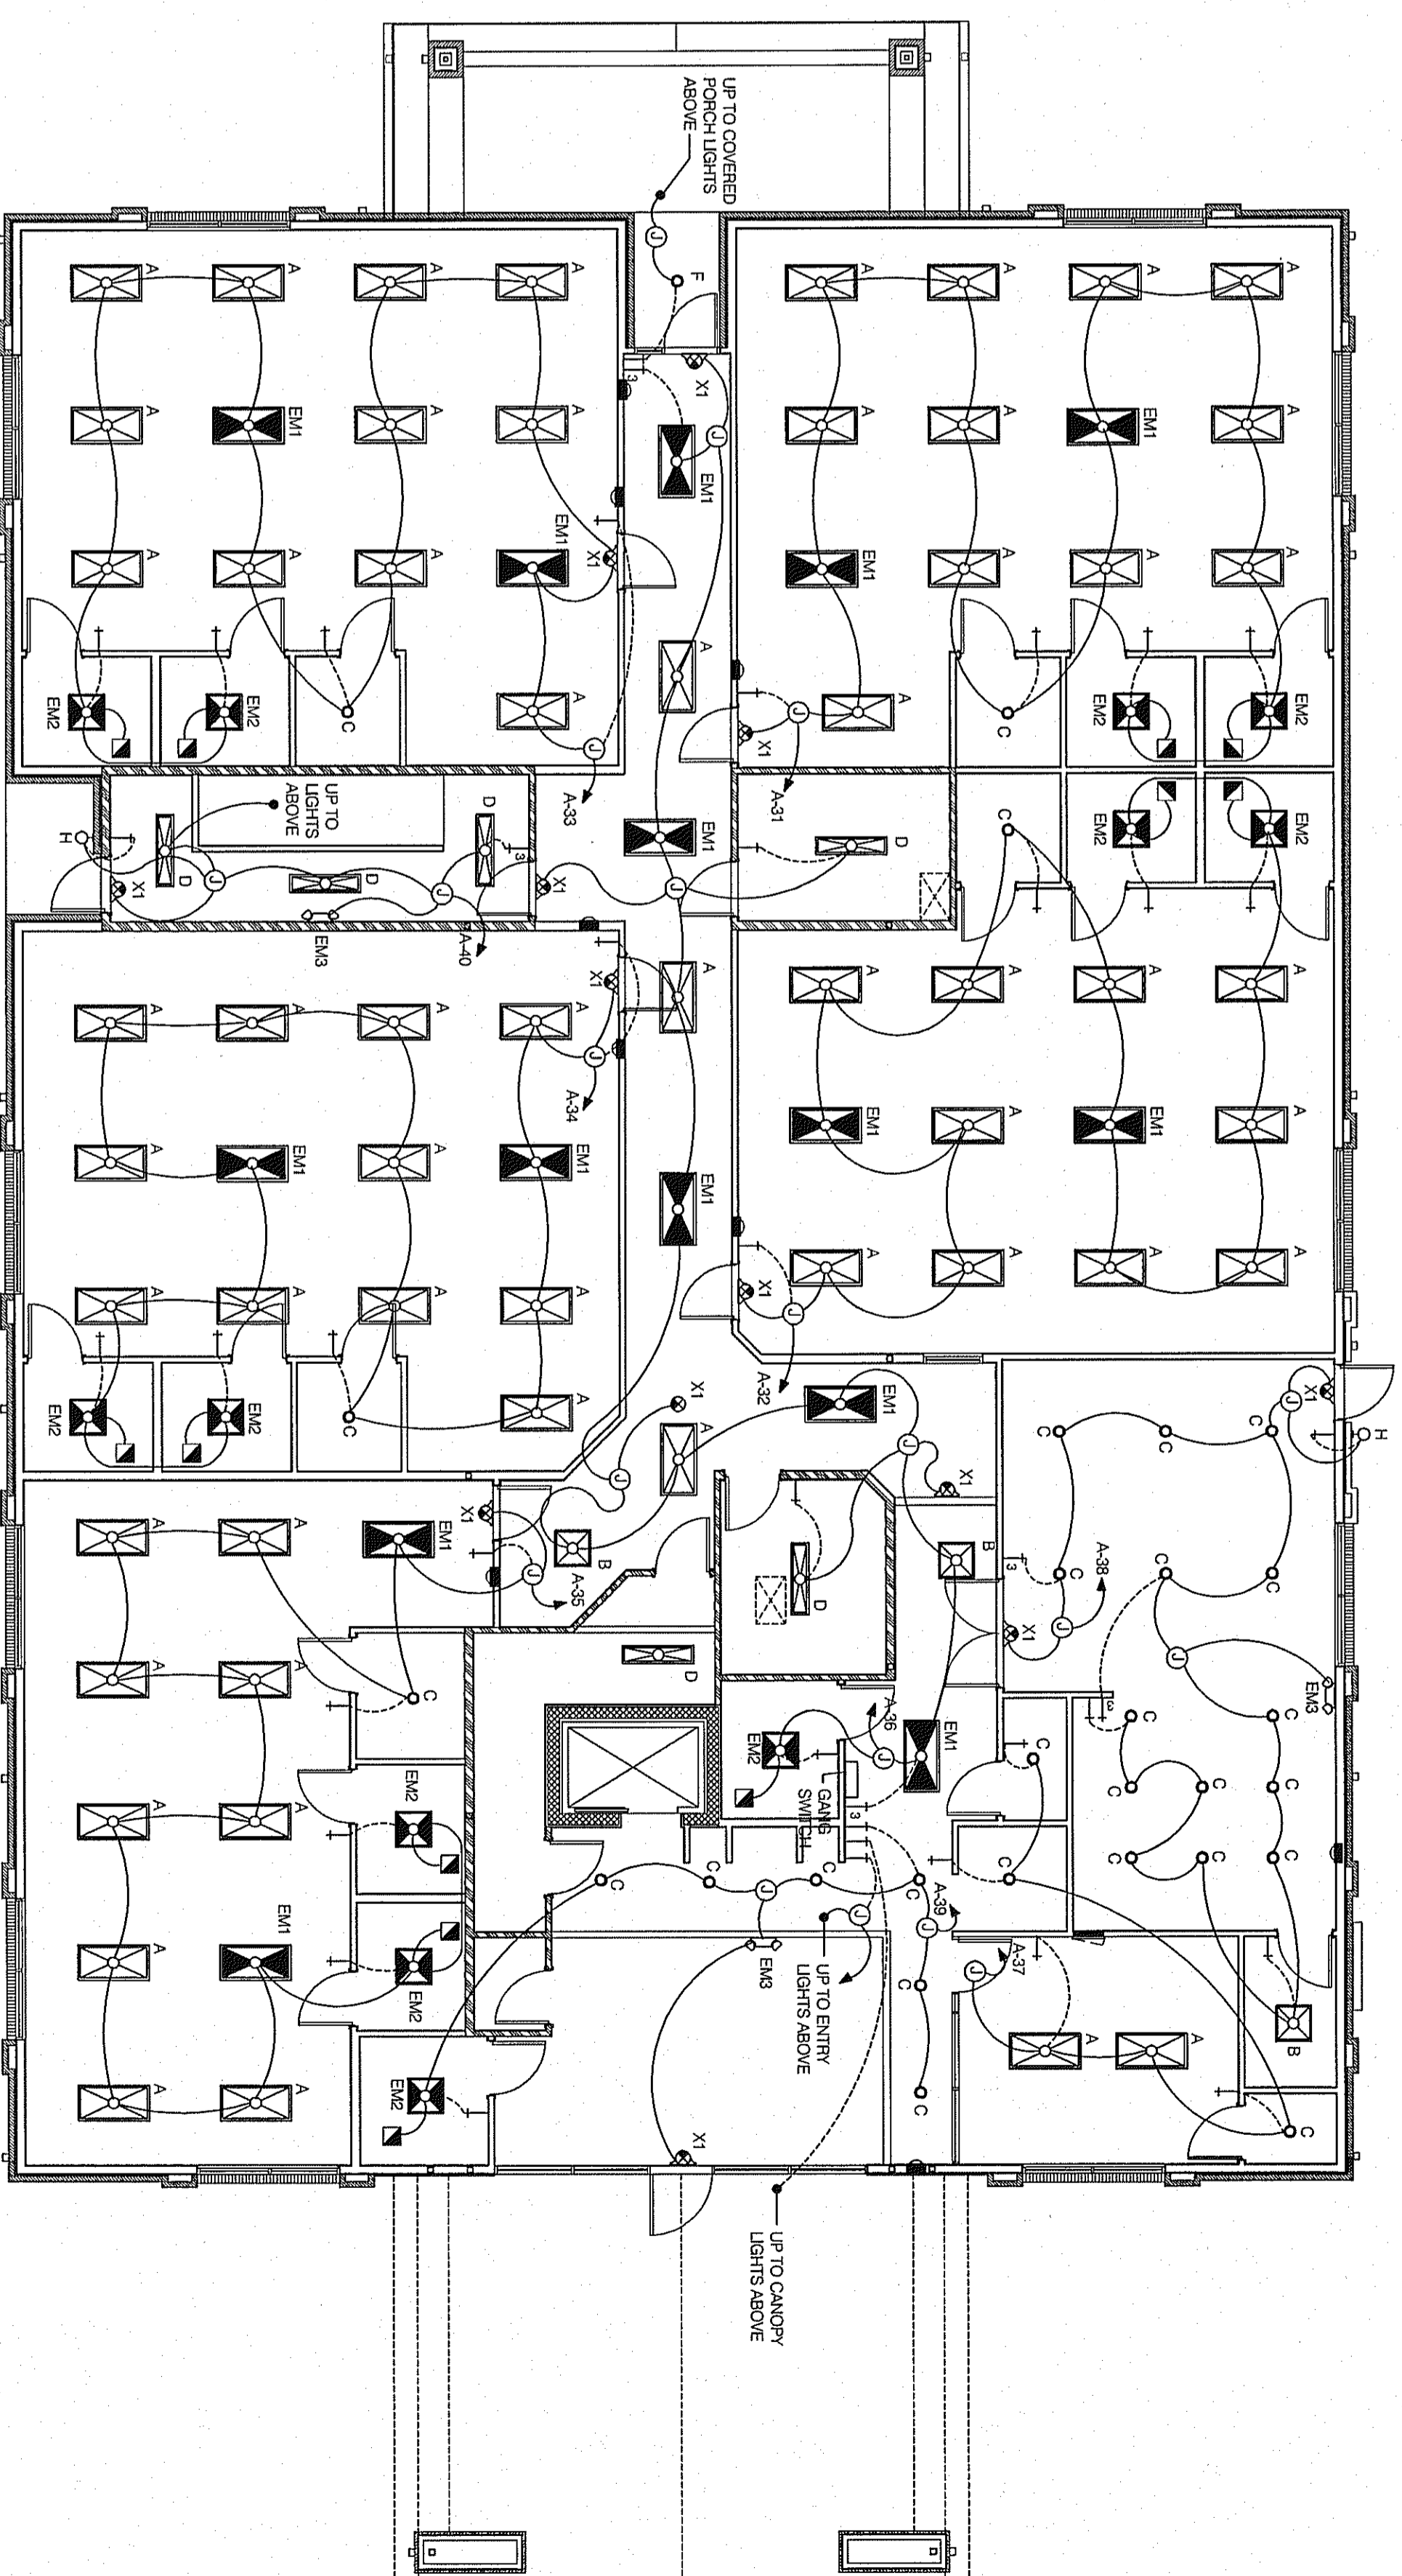

Note:
1. CLASSROOM LIGHTING CIRCUITS ARE ROUTED THROUGH LIGHTING CONTRACTORS CONTROL OF GANG SWITCH LOCATED OUTSIDE THE DIRECTORS OFFICE.

FIRST FLOOR LIGHTING PLAN SCALE: 1/8" = 1'-0"

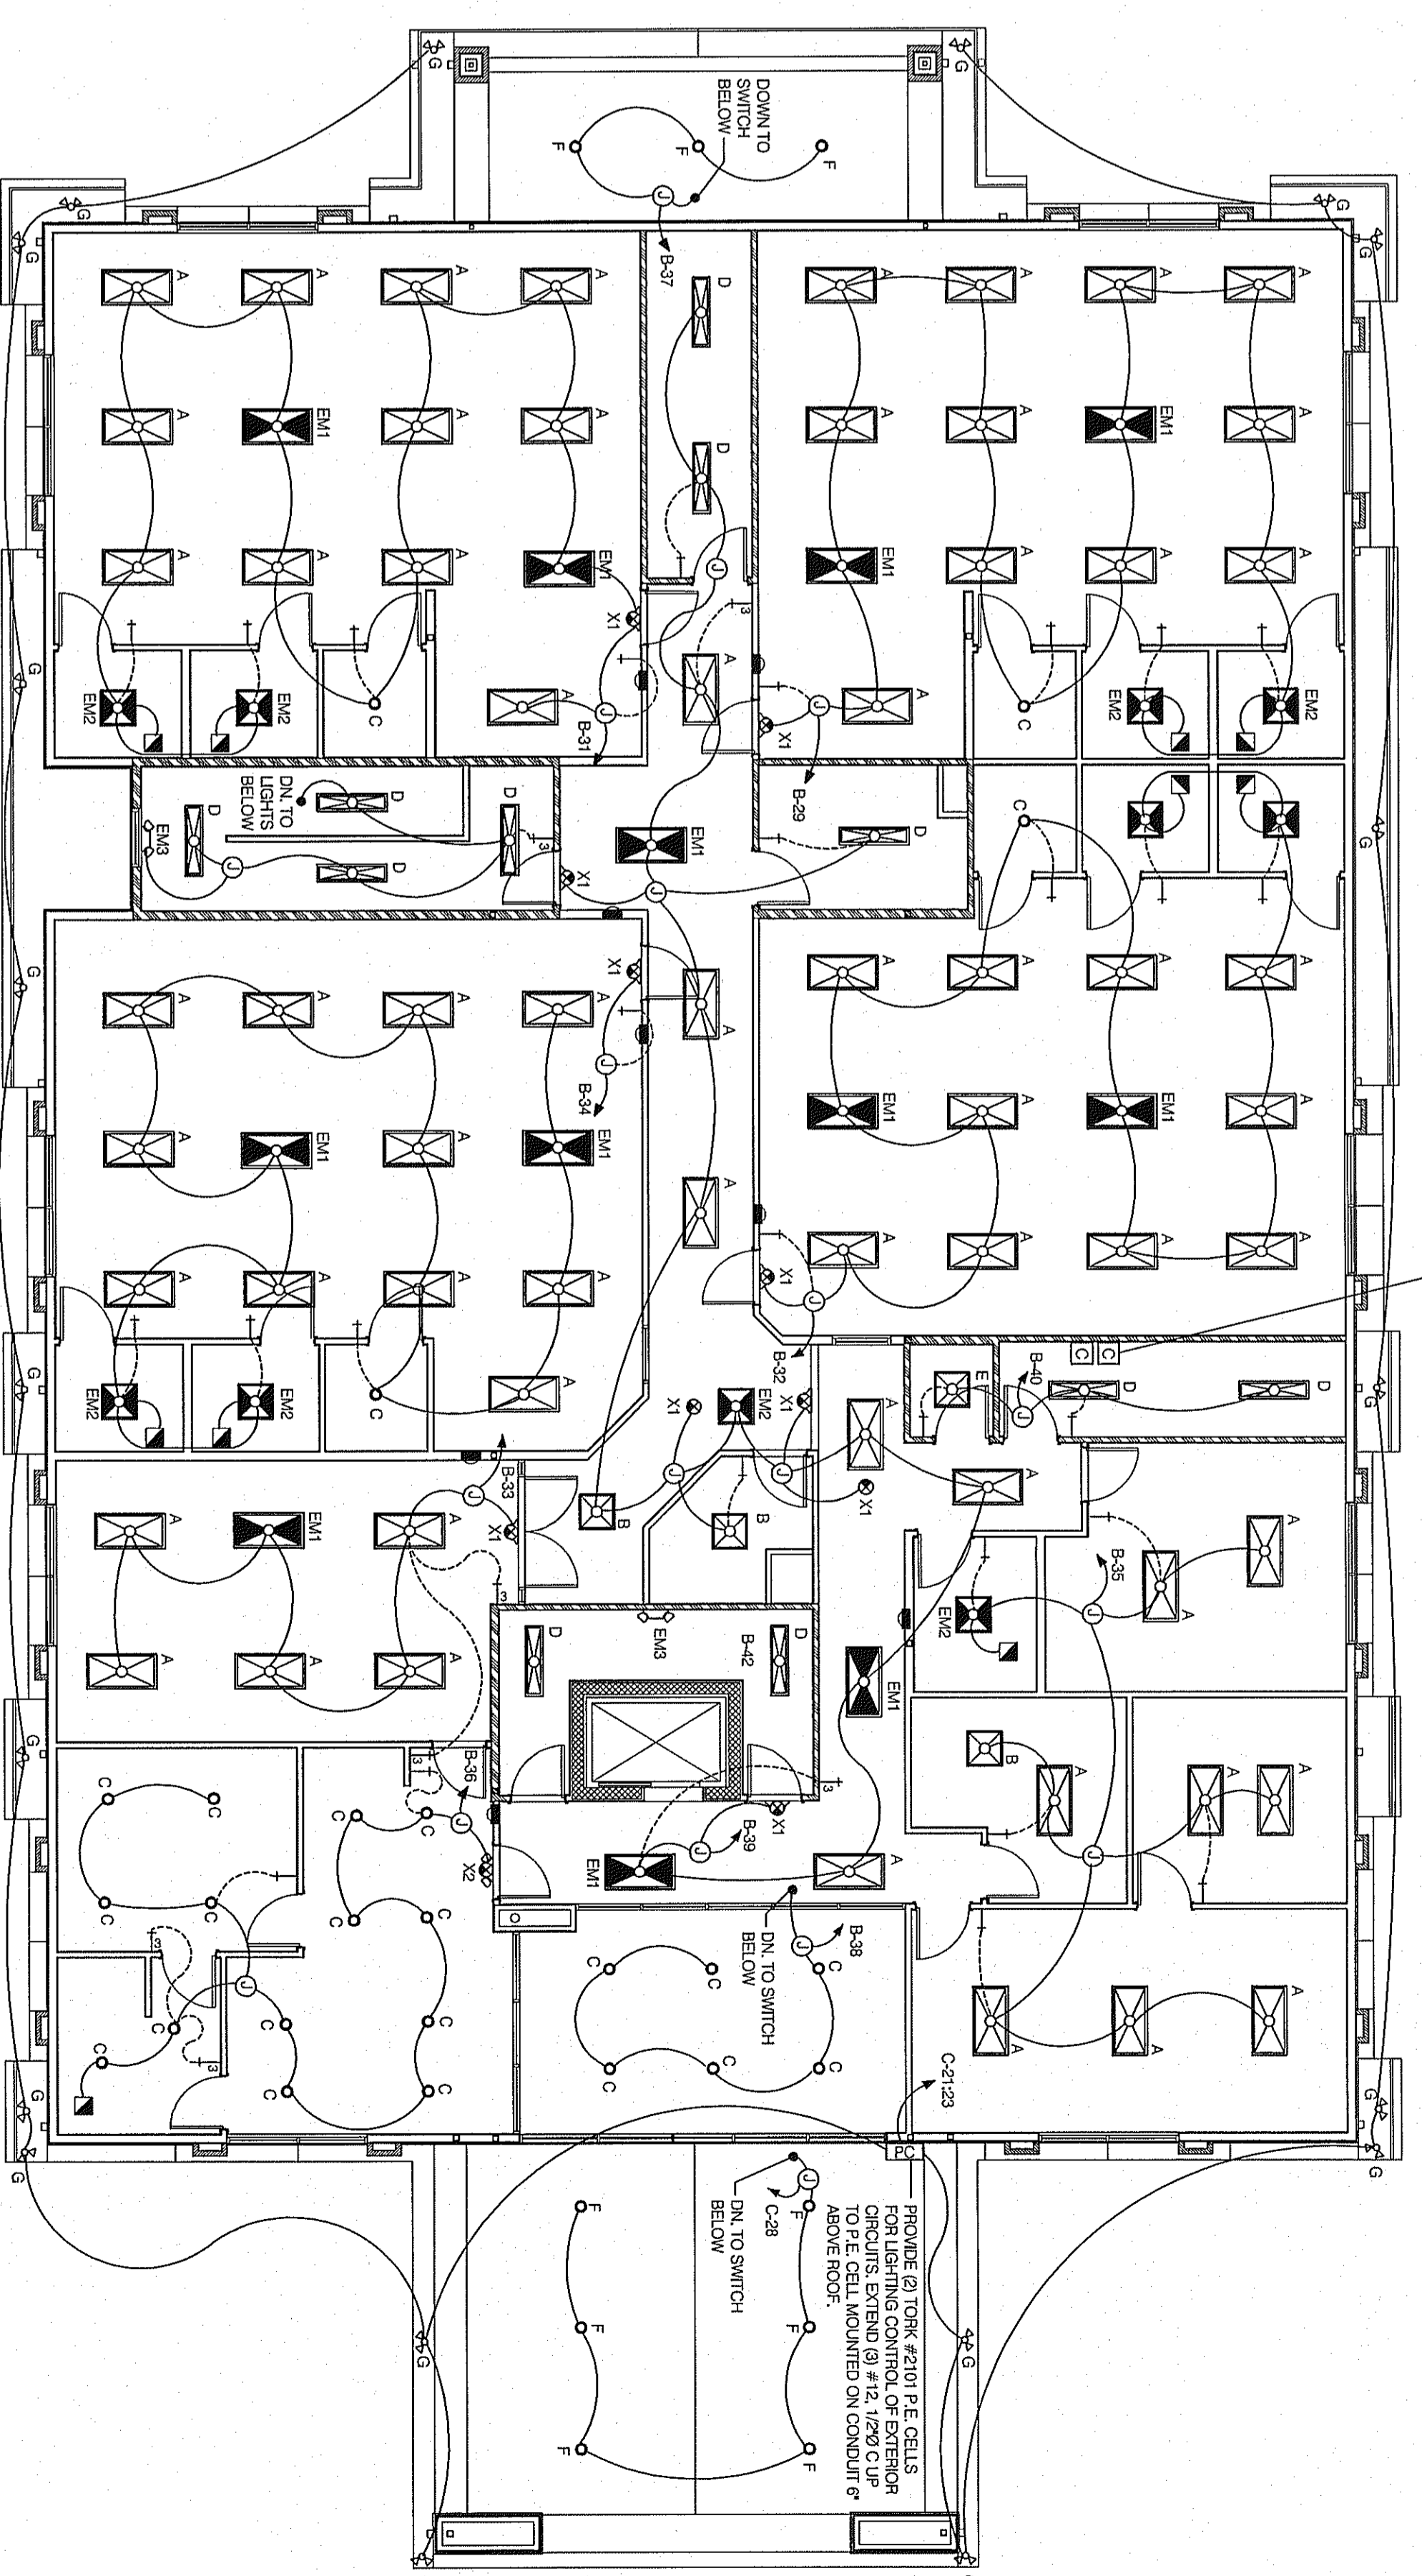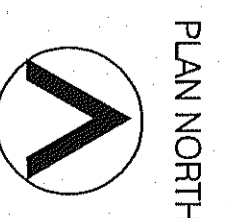

Note:
1. CLASSROOM LIGHTING CIRCUITS ARE ROUTED THROUGH LIGHTING CONTRACTORS CONTROL OF GANG SWITCH LOCATED OUTSIDE THE DIRECTORS OFFICE.

SECOND FLOOR LIGHTING PLAN SCALE: 1/8" = 1'-0"



LIGHTING PLANS



dennis j. dubey, architect
6327 Point Twenty Two
Gainesville, Georgia 30506
Phone (770) 297-7744
Fax (770) 297-9760
E-Mail: djdarch@bellsouth.net

NOT RELEASED FOR CONSTRUCTION

PROJECT LOCATION
3824 OLD ATLANTA ROAD
CLAWSON, GA 30011

REVISIONS

DATE PROJECT NO.
8-17-09 29001

SHEET NO.
E2.0