

PLAN NORTH

ATTIC HVAC PLAN SCALE: 1/8" = 1'-0"



PROJECT LOCATION
3624 OLD ATLANTA ROAD
CLARKSBURG, GA 30041


NOT RELEASED FOR CONSTRUCTION

dennis j. dubey, architect
6327 Point Twenty Two
Gainesville, Georgia 30506
Phone (770) 297-7744
Fax (770) 297-9760
E-Mail: cjdarch@bellsouth.net

REVISIONS

DATE 8-17-09
PROJECT NO. 29001
SHEET NO. M2.0

HVAC PLAN AND DETAILS

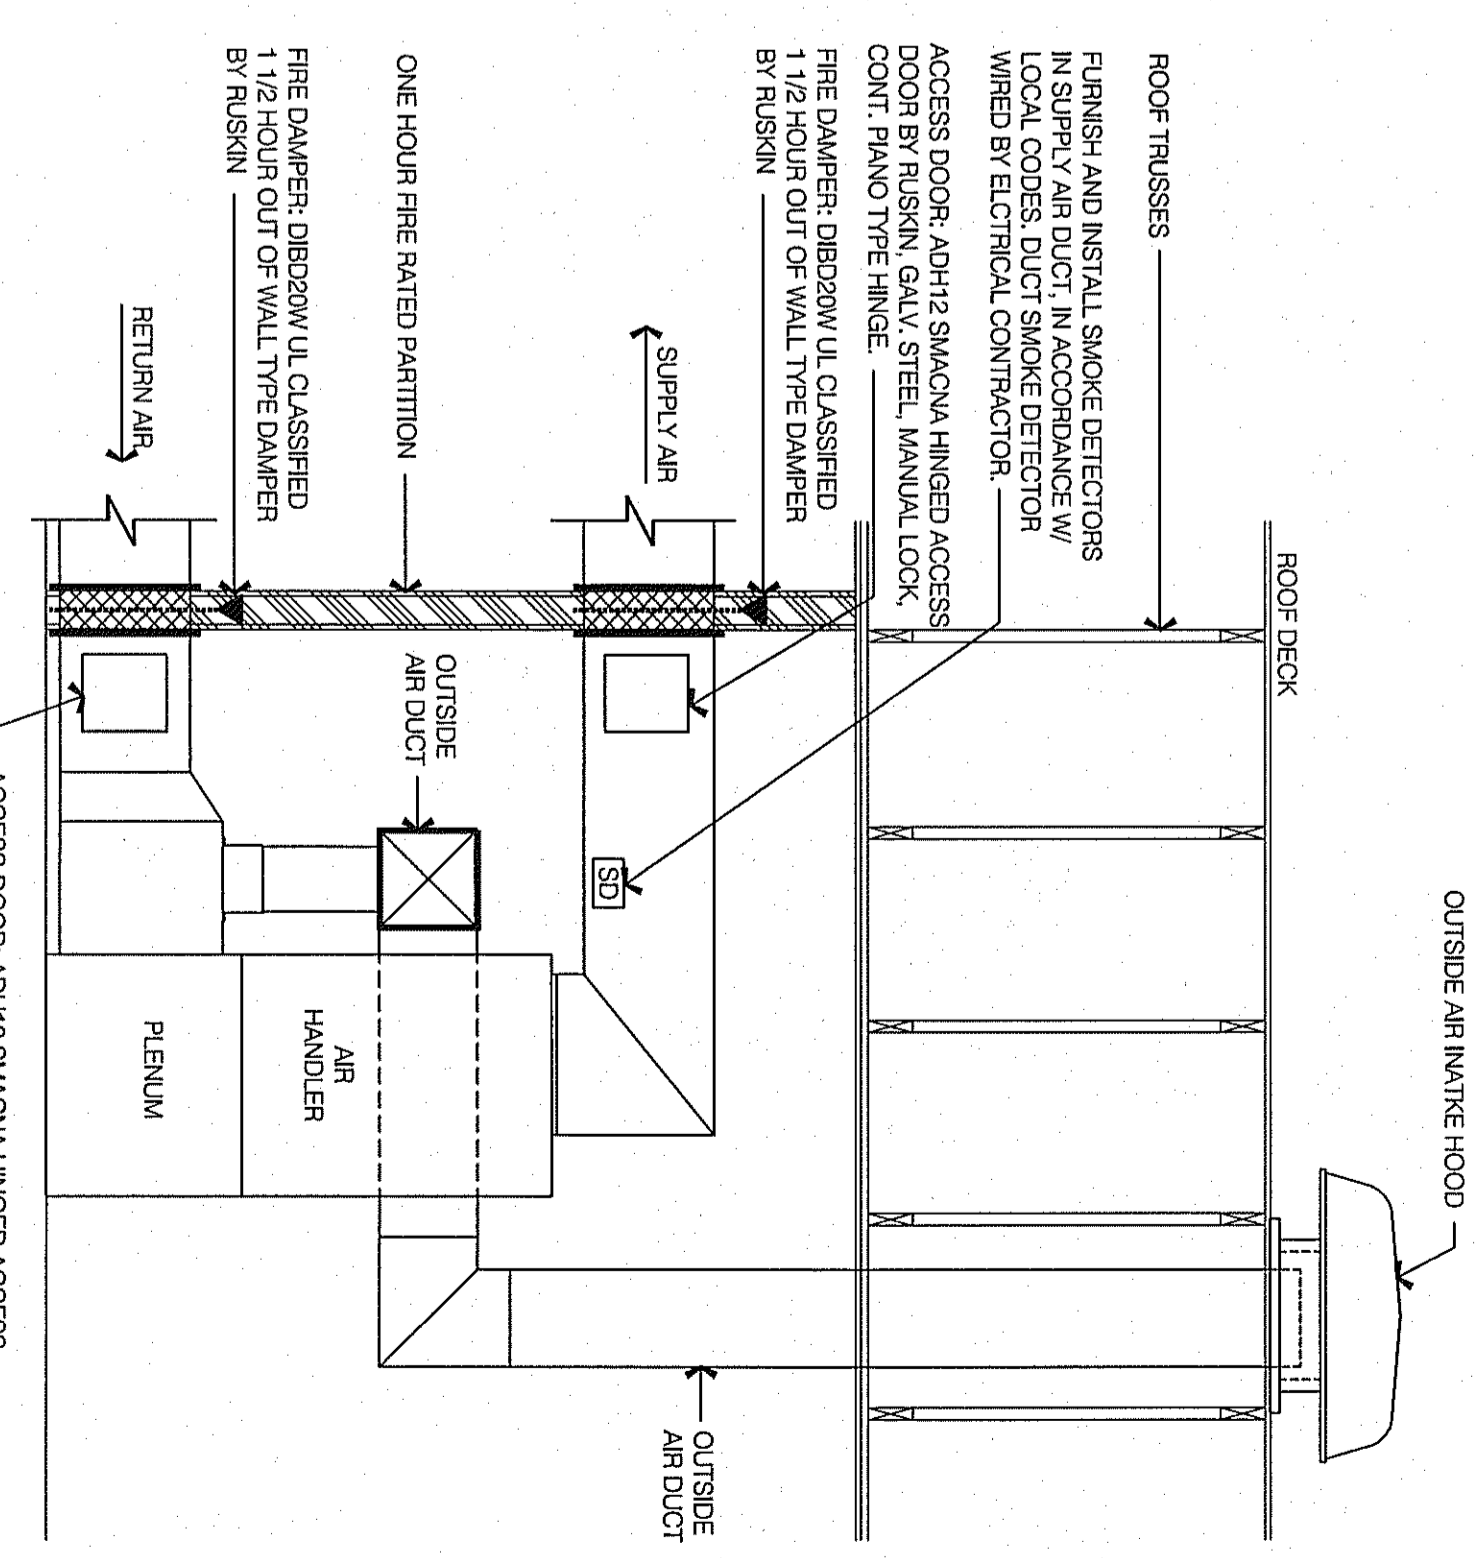

TYPICAL AIR HANDLING UNIT DETAIL SCALE: 1/2" = 1'-0"